


© Whittam Cox Architects - Disclaimer
 This drawing is copyright of WCEC Group Ltd trading as Whittam Cox Architects, and shall not be reproduced nor used for any other purpose without the written permission of the Architects. This drawing must be read in conjunction with all other related drawings and documentation. It is the contractors responsibility to ensure full compliance with the Building Regulations. Do not scale from this drawing, use figured dimensions only. It is the contractors responsibility to check and verify all dimensions on site. Any discrepancies to be reported immediately. IF IN DOUBT ASK.
 Materials not in conformity with relevant British or European Standards/Codes of practice or materials known to be deleterious to health & safety must not be used or specified on this project.

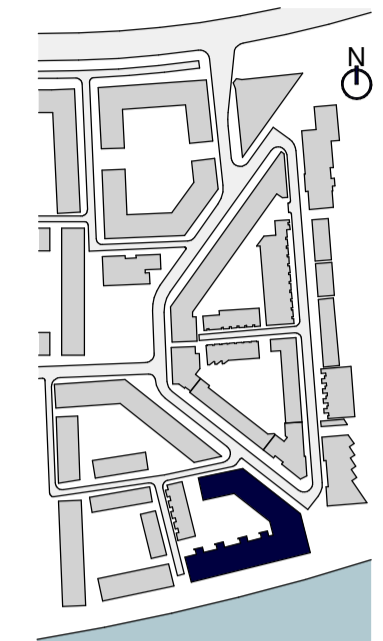

Block Location Plan

- High level containment route
- Gas
- Water
- Drainage pop-up
- Elec
- BT
- TV
- FA Panel
- District Heating
- ⊗ SVP - No connection point
- ⊗ SVP - Dedicated connection point above ground
- ⊗ RWP
- ⊗ Gully

All service locations to be confirmed by M&E engineer.


Tenant to restrict waste to within store until collection. No cage external.

Tenant to issue roof plan details.

Landlord to confirm vent strategy

Landlord to ensure all service openings through compartment party walls are fire stopped and sealed

Landlord to ensure opening in locations where riser is over the unit opening to riser to be fire stopped and sealed

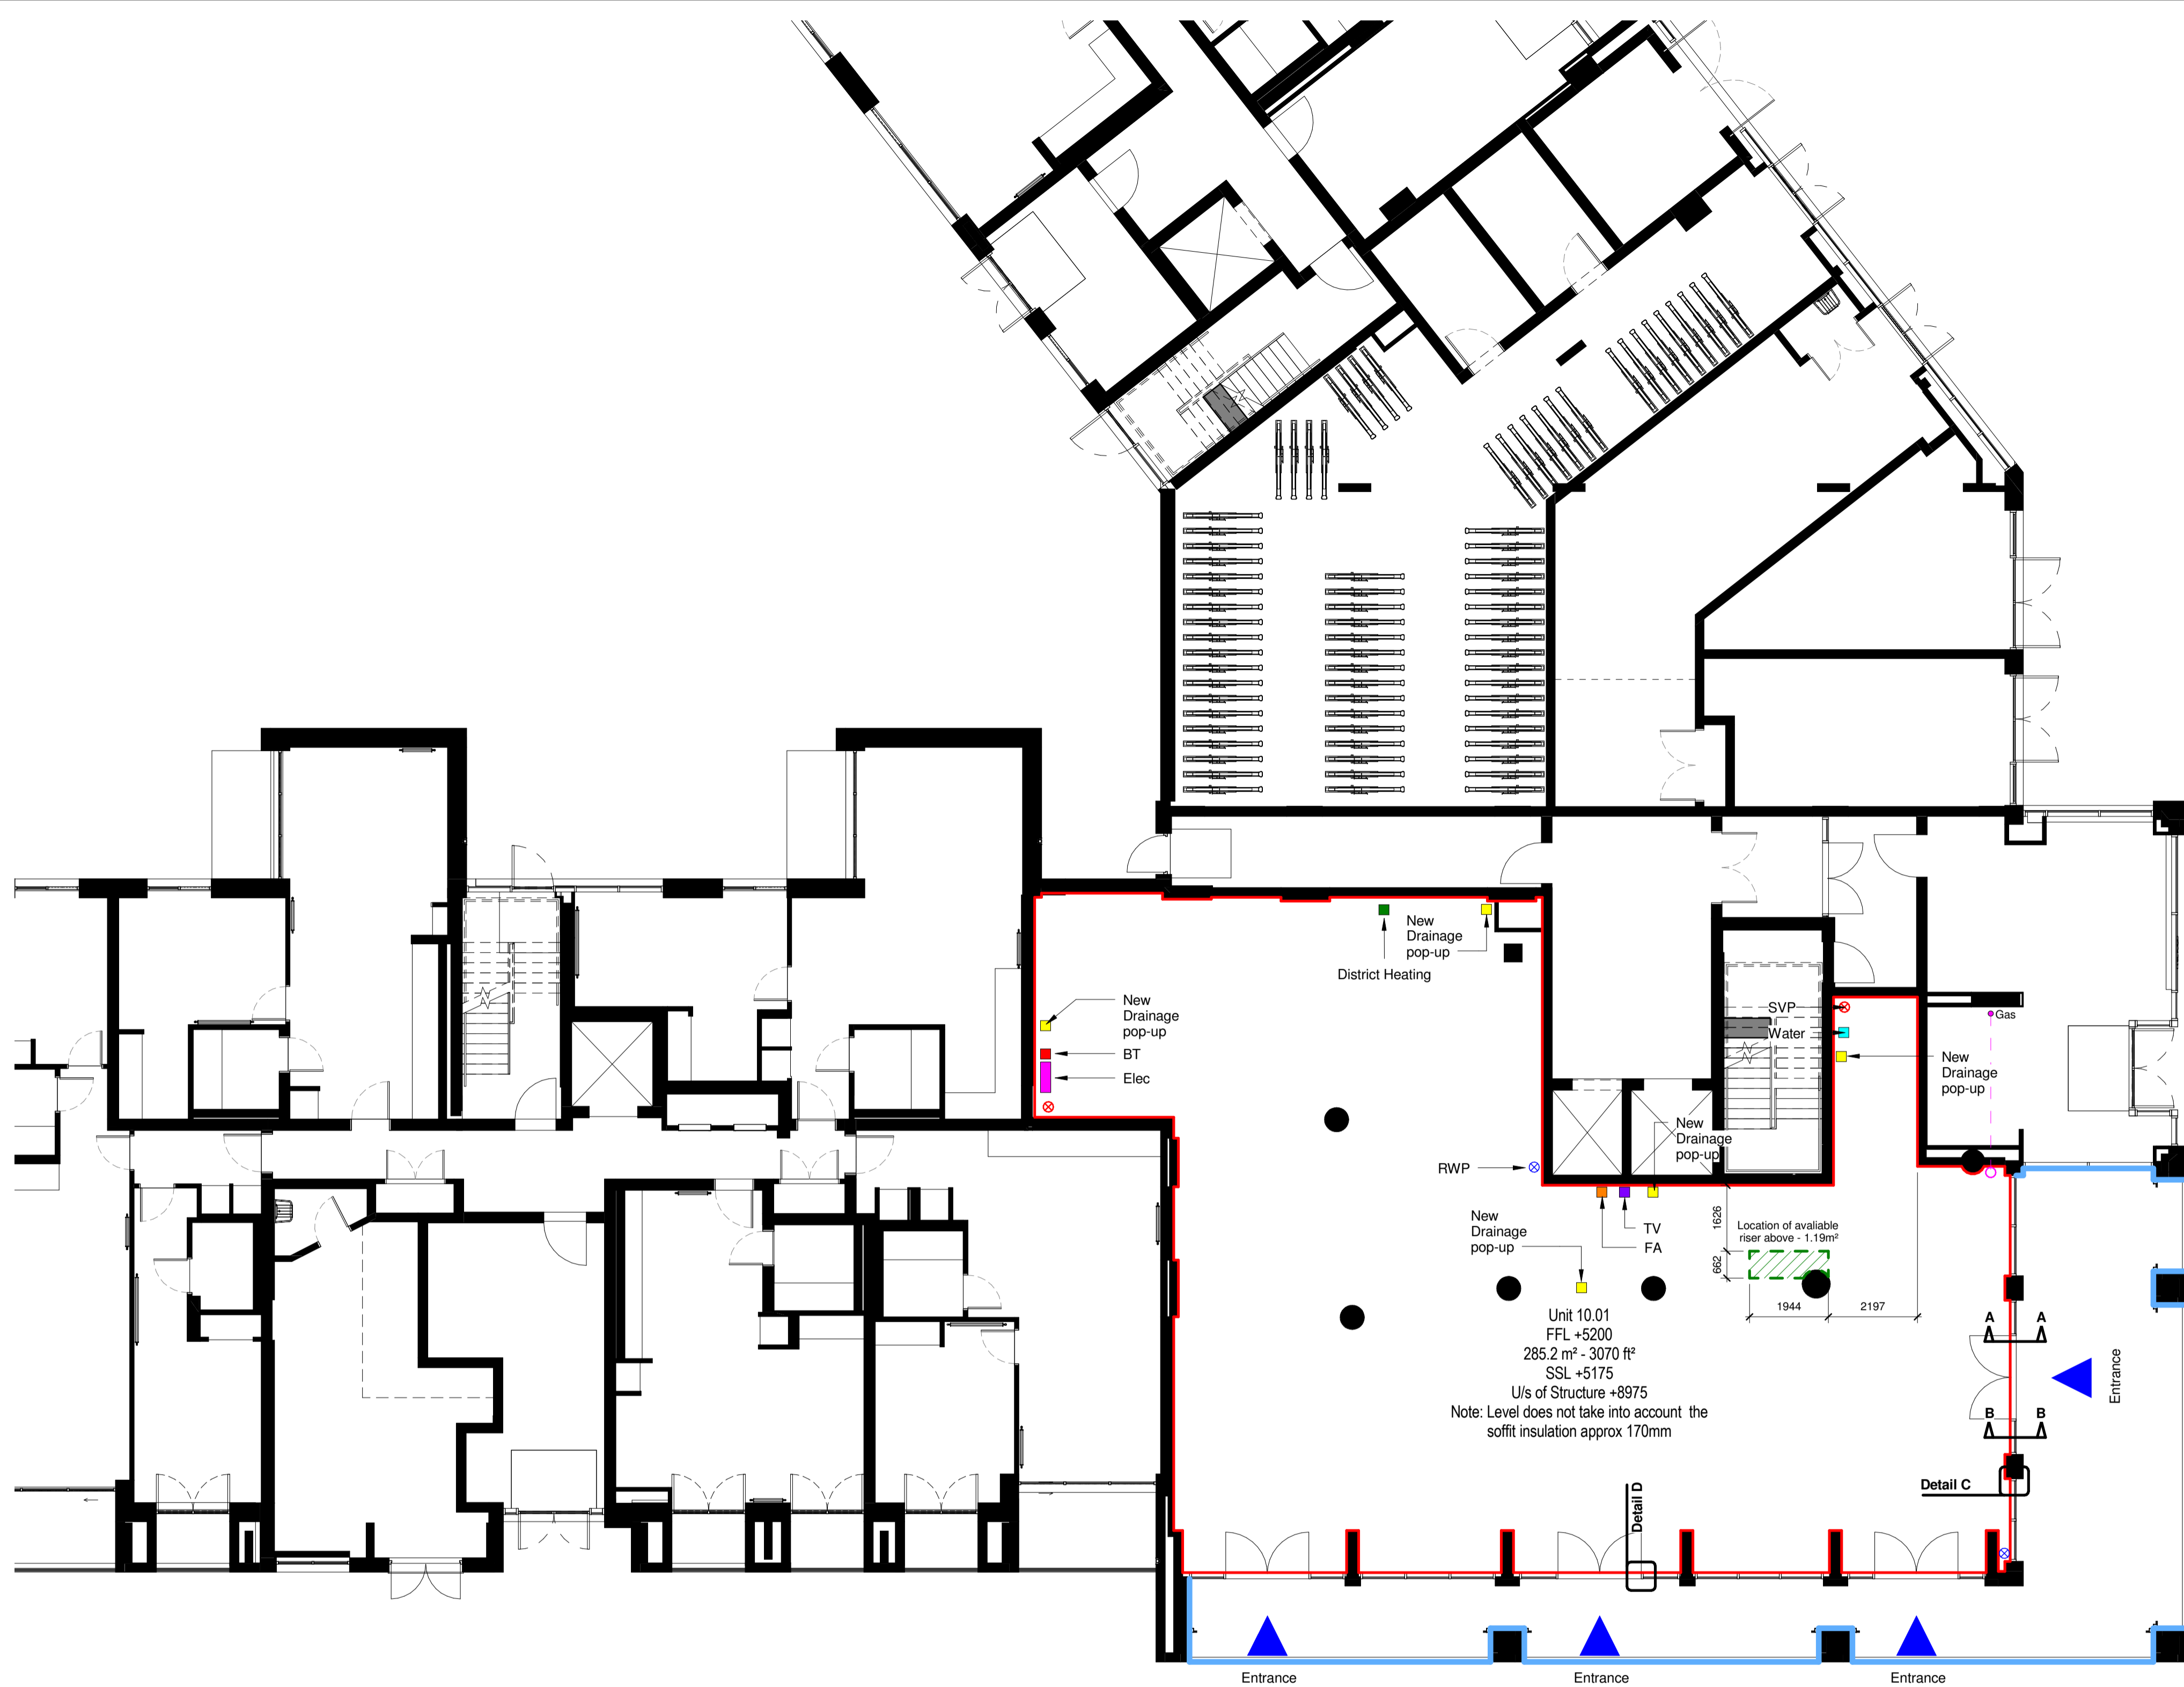

G	05/02/19	Drain Pop Ups amended in line with PB&C comments received 05/02/19	DRJ	DRJ
F	05/02/19	New Tenant Drain Points added in line with PB&C mark up received 30-01-2019	DRJ	DRJ
D	05/03/18	Drainage locations reviewed in line with Tate survey.	IW	JH
E	04.05.18	Drawing Updated	AP	CH
C	10.03.17	Services Revised	LO	CH
B	21/10/16	Updated in line with GHA comments for inclusion in tenants pack.	IW	CH
A	20/07/16	Updated for inclusion in tenant pack	IW	CH
No	Date	Description	By	Ckd



PROJECT
 Plot 10.01 - Royal Wharf Development Phase 1

TITLE
 Plot 10.01 - Commercial Unit 10.01 Plan

DRAWING STATUS
 FOR INFORMATION

DRAWN	JS	CHECKED	CH
SCALE	As indicated @ A1		
DATE	15/01/16		

Whittam Cox ARCHITECTS
 Formerly WCEC architects
 whittamcox.com

Chesterfield / 01246 260 261
 London / 02033 880 019
 Leeds / 01133 366 018

JOB NO.	DRAWING NO.	REV
13-500	A_00_10.01_300	G